






02 REAR ELEVATION
SCALE: 1/4" = 1'-0" LEFT SIDE
RIGHT SIDE OPP.

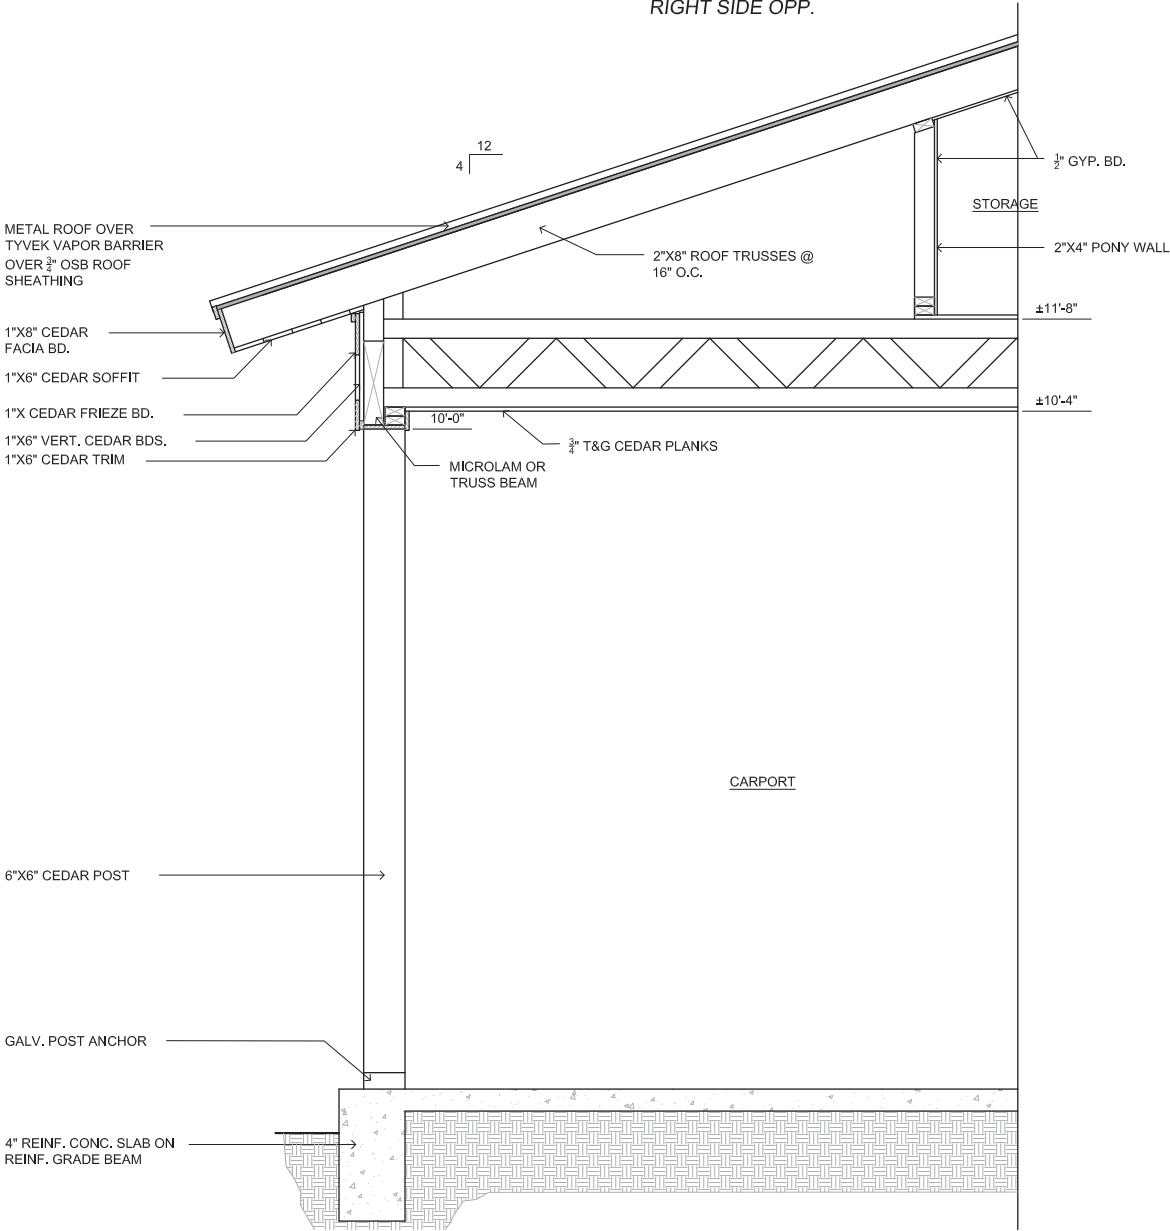

04 WALL SECTION
SCALE: 3/4" = 1'-0"

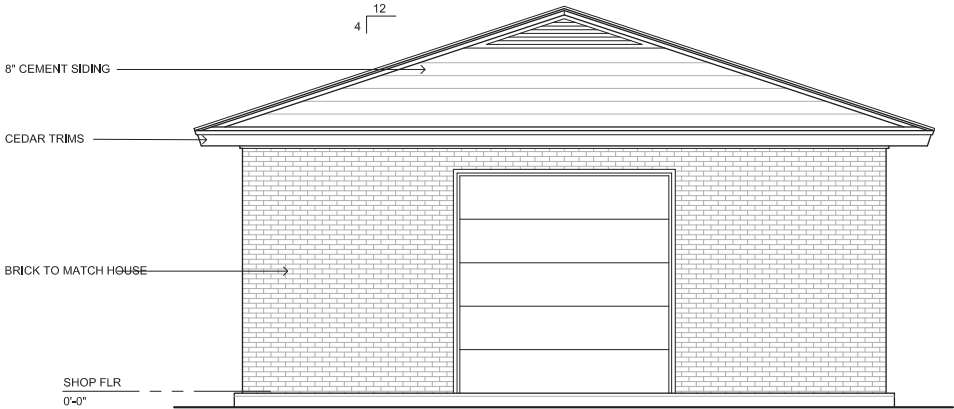

03 RIGHT ELEVATION
SCALE: 1/4" = 1'-0" REAR

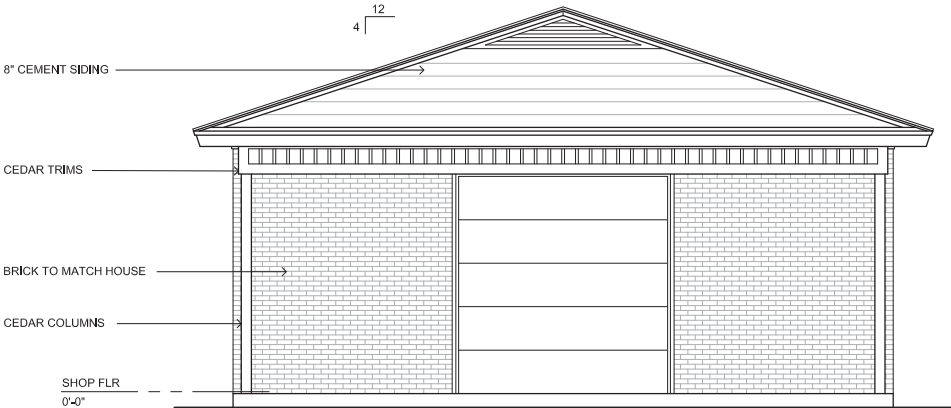

01 RIGHT ELEVATION
SCALE: 1/4" = 1'-0" FRONT

These plans are the property of Kevin Travell and are not to be reproduced, traced or re-used without the written permission of "Kevin Travell. It is the sole responsibility of the builder/owner to verify all deed restrictions, local and national building codes and dimensions prior to any construction.

NEW SHOP BUILDING
AT
7504 Bursey Rd.
North Richland Hills, Texas 76182

CLIENT
APPROVAL
BY: _____
DATE: _____

903 N. Clinton Ave
Dallas, Texas 75208
817-291-3875

DESIGN BY
KEVIN TRAVELL

DATE: 05-29-17
REV: 07-30-17


SHEET TITLE
ELEVATIONS

A.203


DOOR SCHEDULE						
DOOR	TYPE	DOOR				REMARKS
		THK.	WIDTH	HEIGHT	MAT.	
①	GARAGE	1-3/4"	10'-0"	10'-0"	FIBERGLASS	INSULATED AND WEATHERSTRIPPING
②	ENTRY	1-3/4"	2'-8"	6'-8"	METAL	
③	PANEL	1-3/8"	2'-0"	6'-8"	SC. WOOD	
④	PANEL	1-3/8"	2'-8"	6'-8"	SC. WOOD	

EXISTING DETACHED STRUCTURES WILL BE REMOVED IMMEDIATELY UPON COMPLETION OF NEW BUILDING

WINDOW SCHEDULE						
DOOR	TYPE	WIDTH	HEIGHT	MAT.	HEAD	REMARKS
⬡	SINGLE HUNG	±2'-11"	±5'-0"	VINYL	6"-10"	TO MATCH HOUSE

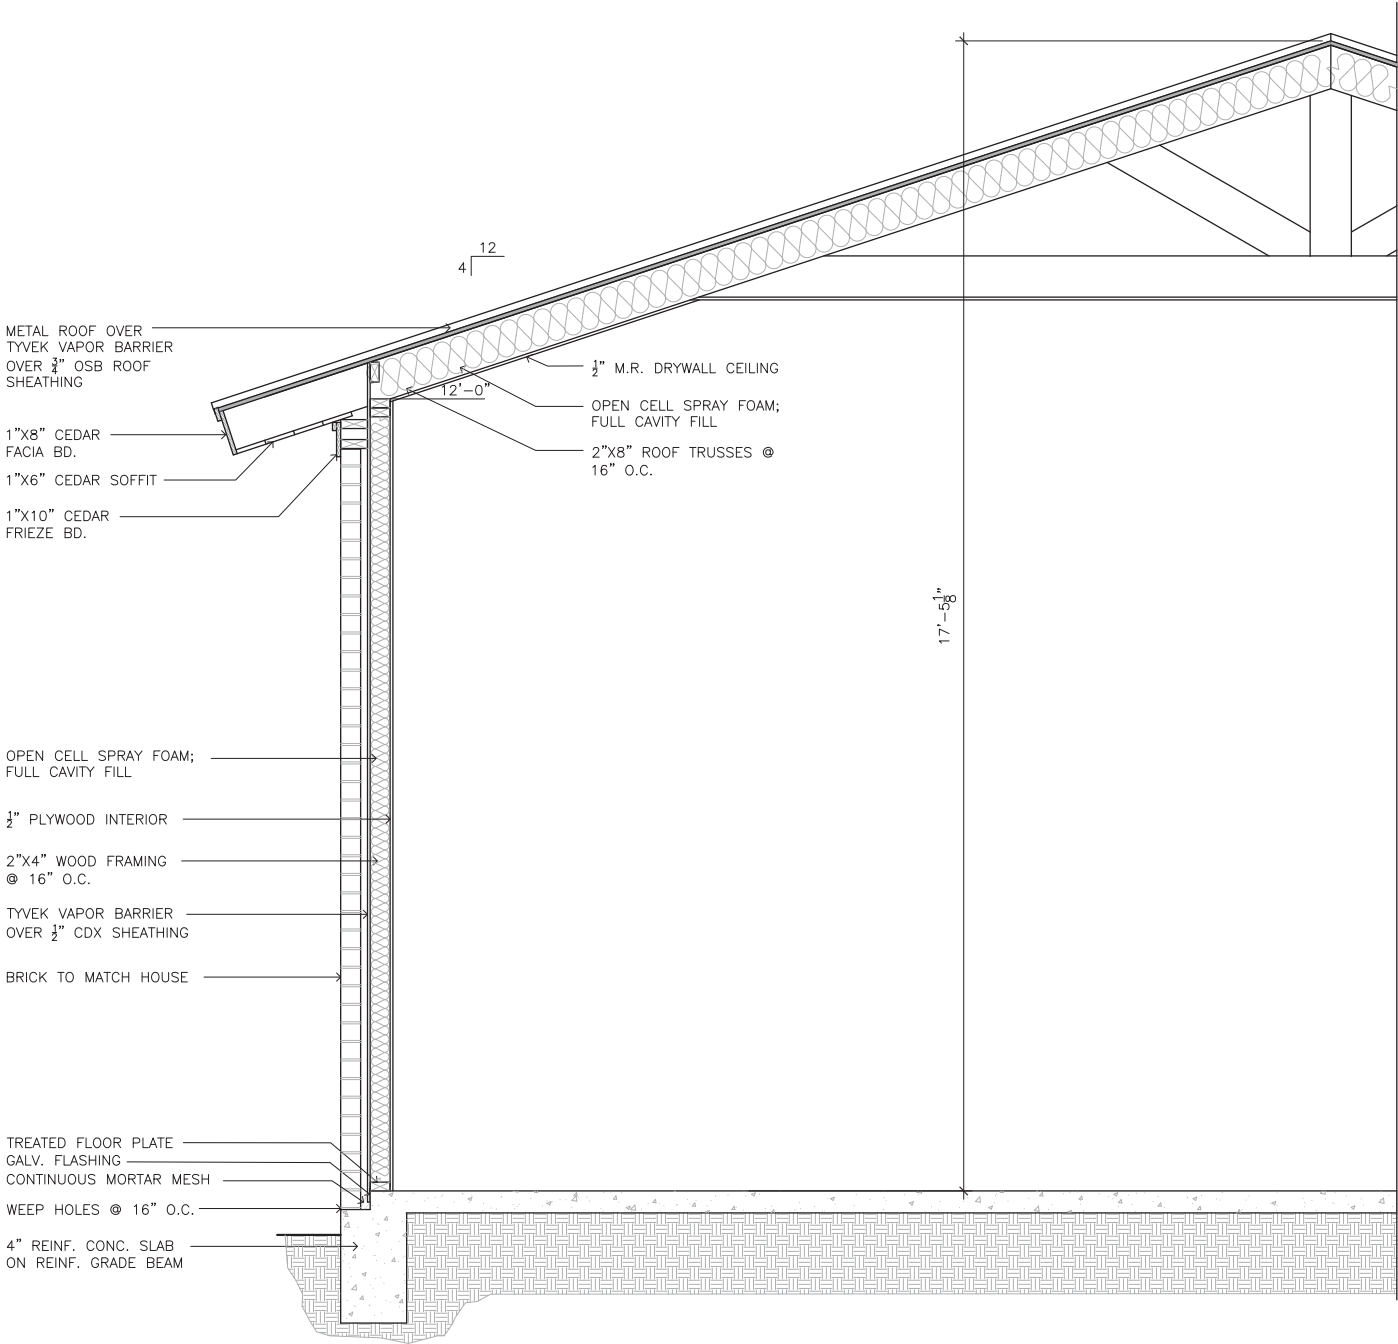

02 WALL SECTION
SCALE: 3/4" = 1'-0"

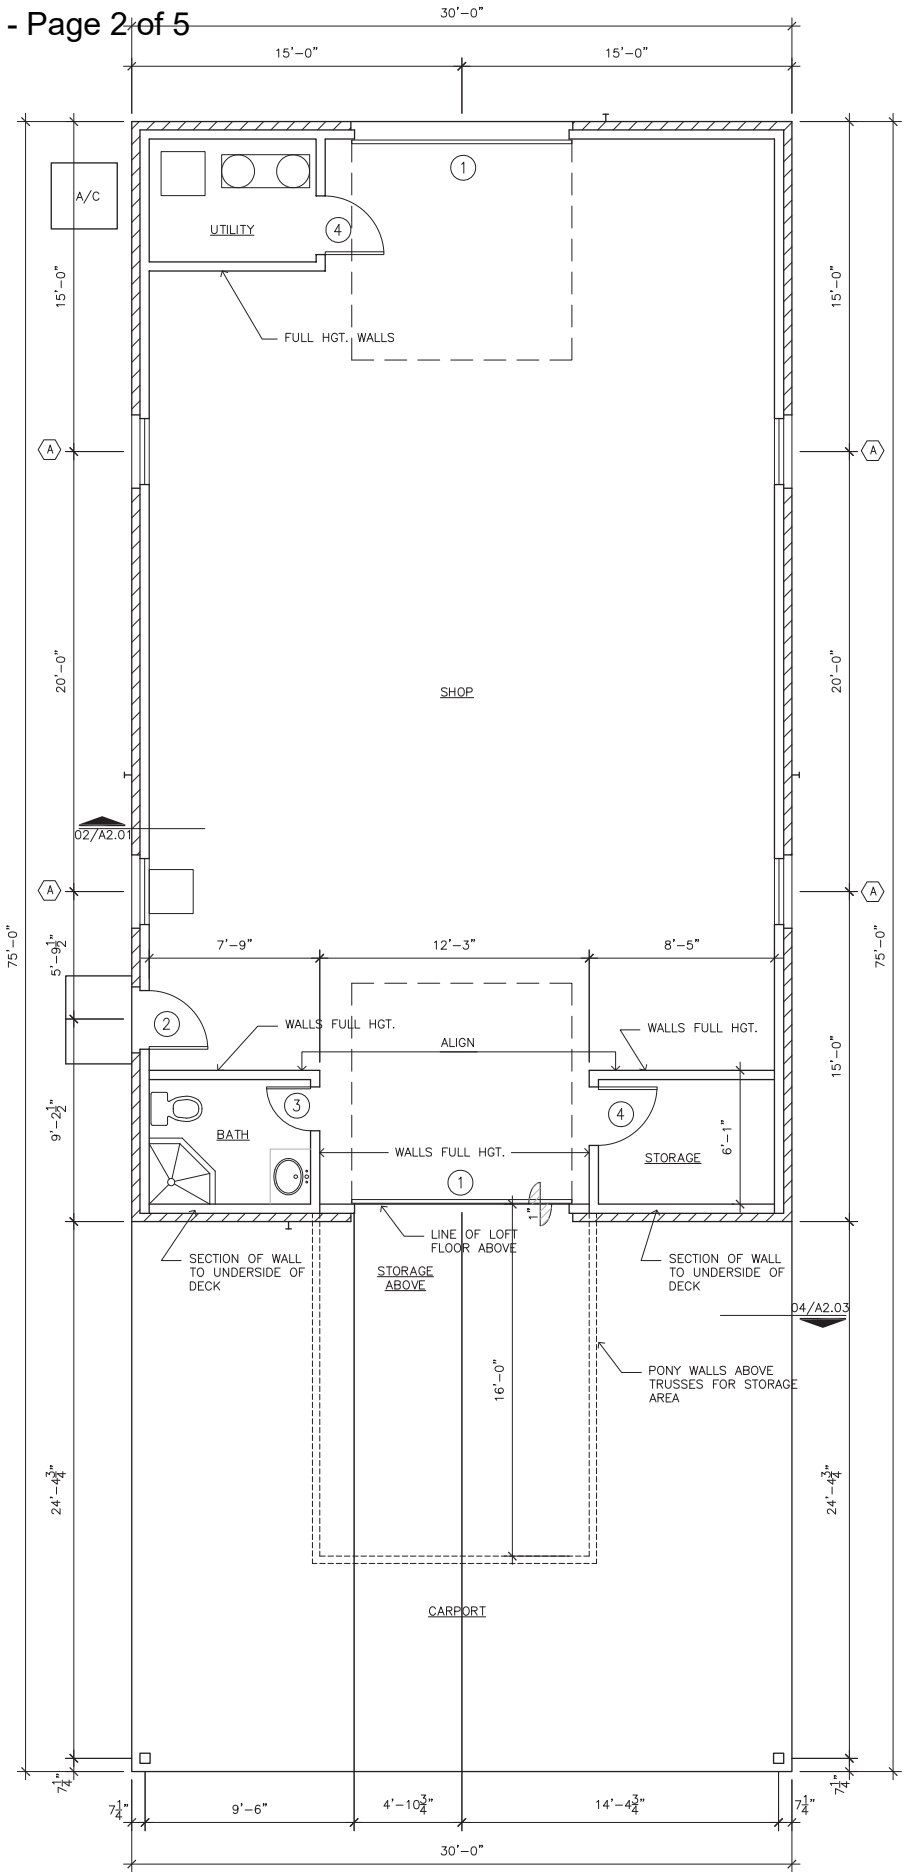

01 CONSTRUCTION PLAN
SCALE: 1/4" = 1'-0" 1,376 SF A/C



These plans are the property of Kevin Travell and are not to be reproduced, traced or reused without the written permission of Kevin Travell. It is the sole responsibility of the builder/owner to verify all deed restrictions, local and national building codes and dimensions prior to any construction.

NEW SHOP BUILDING
AT
7504 Bursey Rd.
North Richland Hills, Texas 76182

CLIENT APPROVAL
BY: _____
DATE: _____


903 N. Clinton Ave
Dallas, Texas 75208
817-291-3875

DESIGN BY
KEVIN TRAVELL


DATE: 05-29-17
REV: 08-01-17

SHEET TITLE
FLOOR PLAN

A.201

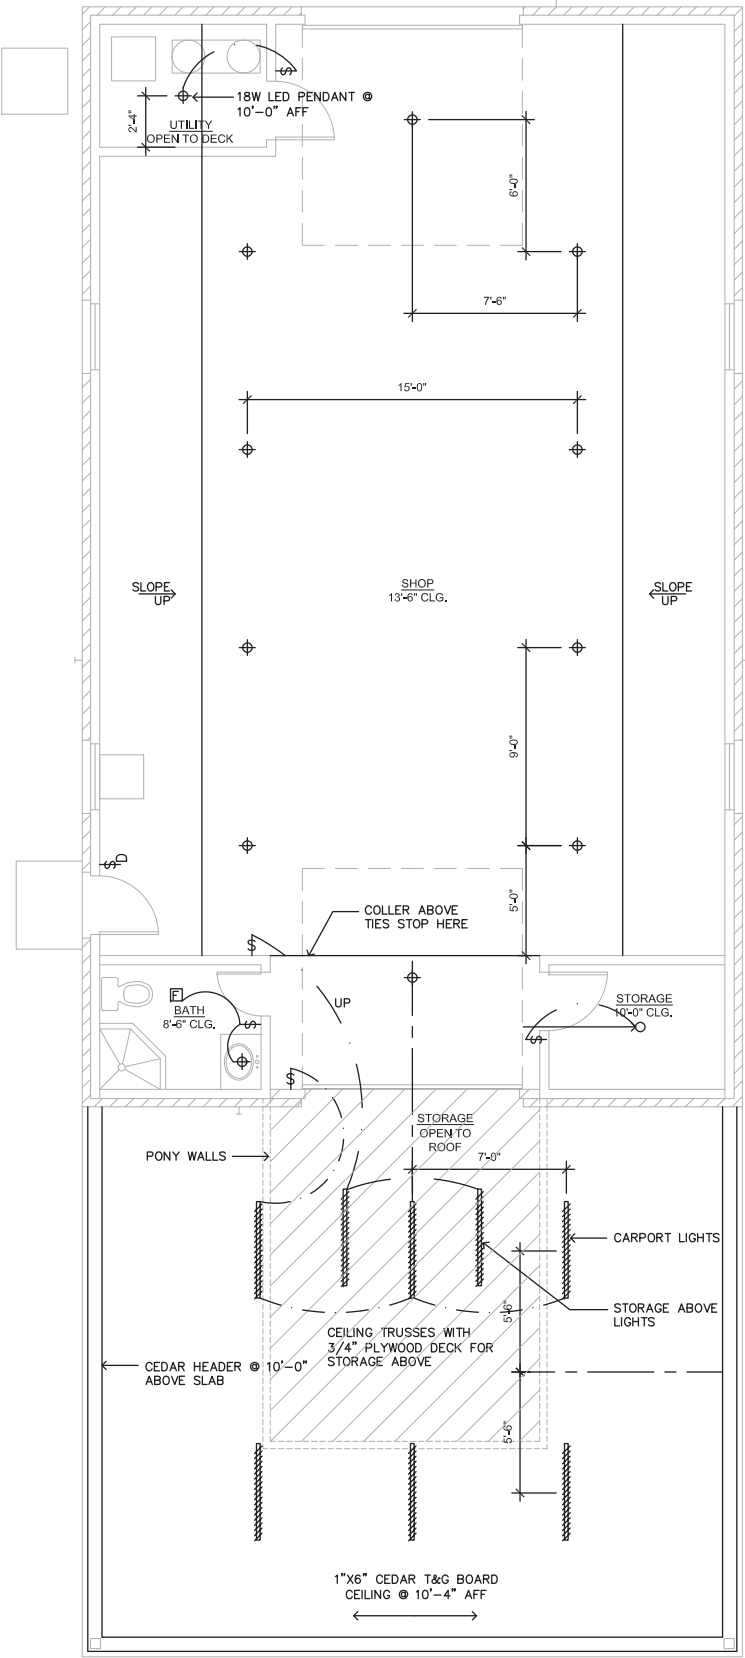

02 **REFLECTED CEILING PLAN**
SCALE: 1/4" = 1'-0"

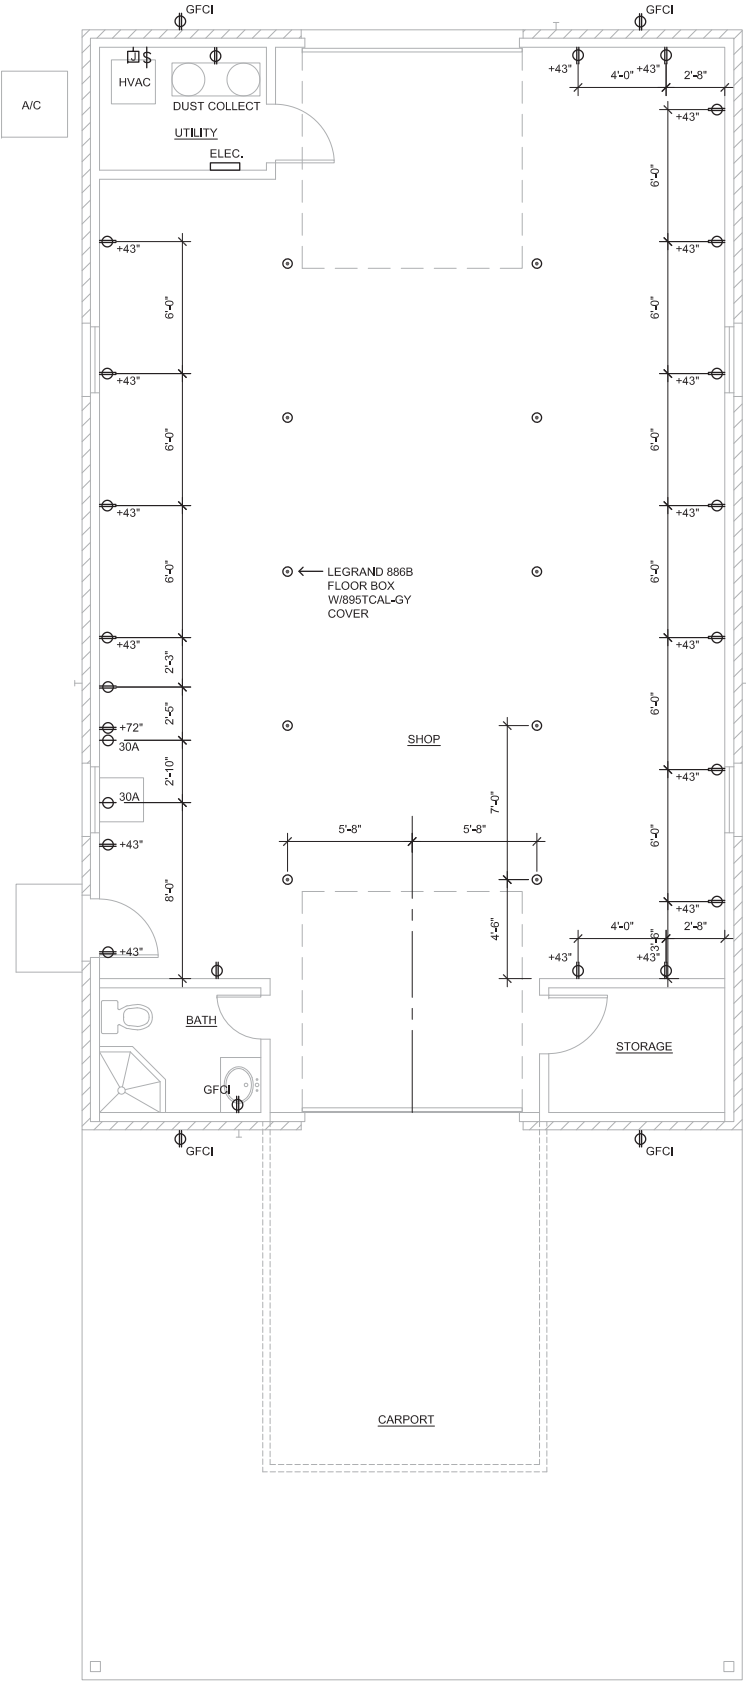

01 **ELECTRICAL PLAN**
SCALE: 1/4" = 1'-0"

These plans are the property of Kevin Travell and are not to be reproduced, traced or re-used without the written permission of "Kevin Travell. It is the sole responsibility of the builder/owner to verify all deed restrictions, local and national building codes and dimensions prior to any construction.

NEW SHOP BUILDING
AT
7504 Bursey Rd.
North Richland Hills, Texas 76182

CLIENT APPROVAL
BY: _____
DATE: _____


903 N. Clinton Ave
Dallas, Texas 75208
817-291-3875

DESIGN BY
KEVIN TRAVELL

DATE: 05-29-17
REV: 07-30-17

SHEET TITLE
RCP/ELEC PLANS

A.202

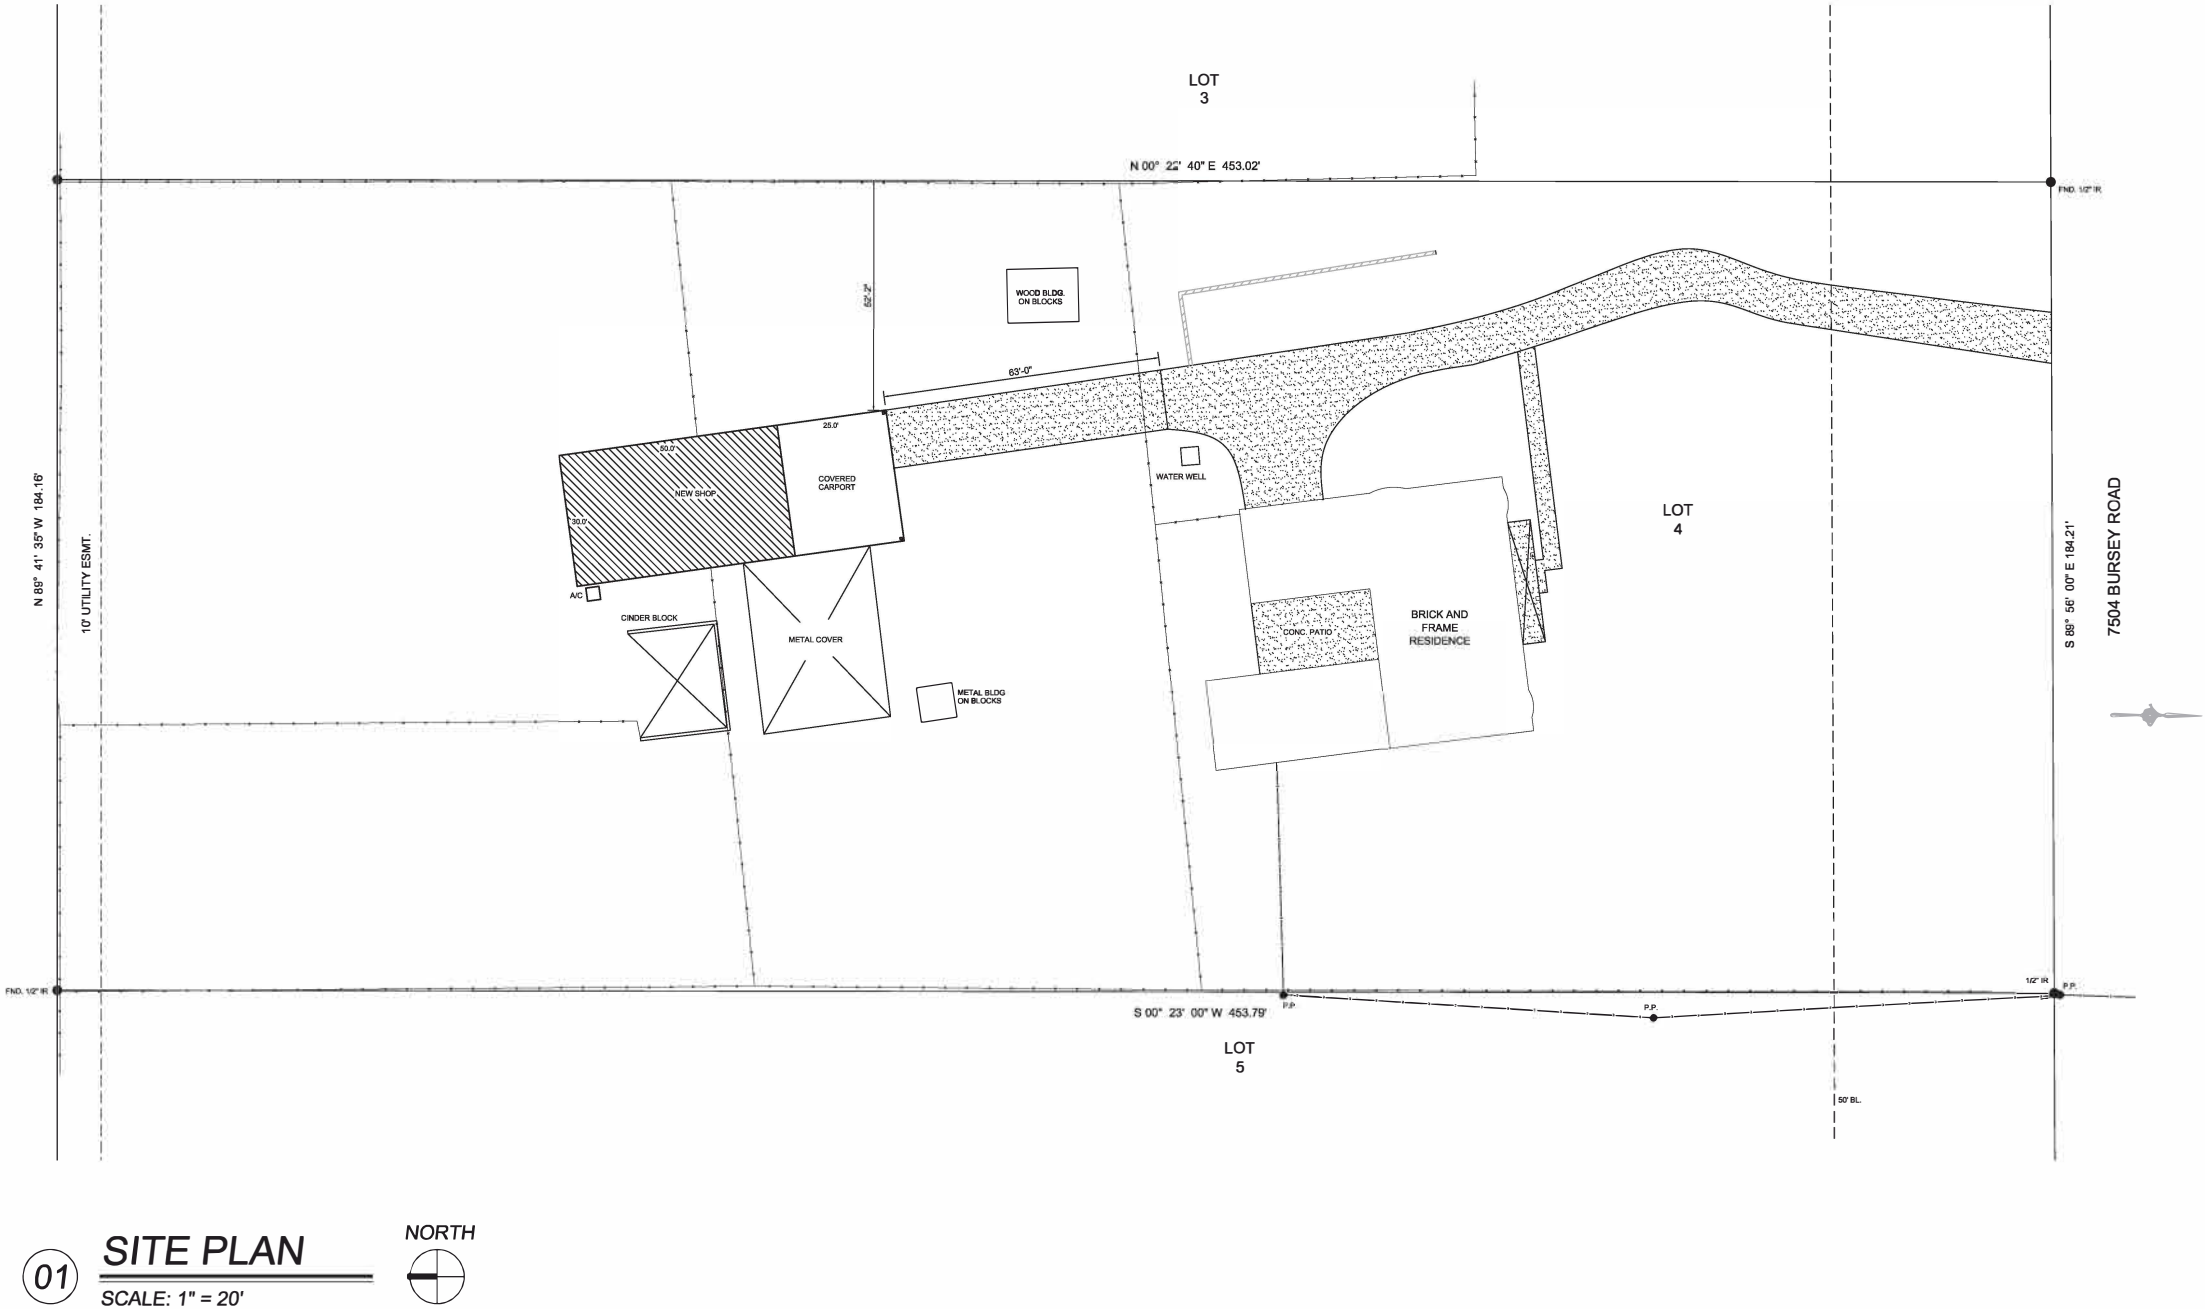

01 **SITE PLAN**
SCALE: 1" = 20'

NORTH

These plans are the property of Kevin Travell and are not to be reproduced, traced or re-used without the written permission of "Kevin Travell". It is the sole responsibility of the builder/owner to verify all deed restrictions, local and national building codes and dimensions prior to any construction.

NEW SHOP BUILDING
AT
7504 Bursey Rd.
North Richland Hills, Texas 76182

CLIENT APPROVAL
BY: _____
DATE: _____

903 N. Clinton Ave
Dallas, Texas 75208
817-291-3875


DESIGN BY
KEVIN TRAVELL

DATE: 06-10-17
REV: _____

SHEET TITLE
SURVEY

A.204

Location of Existing Buildings

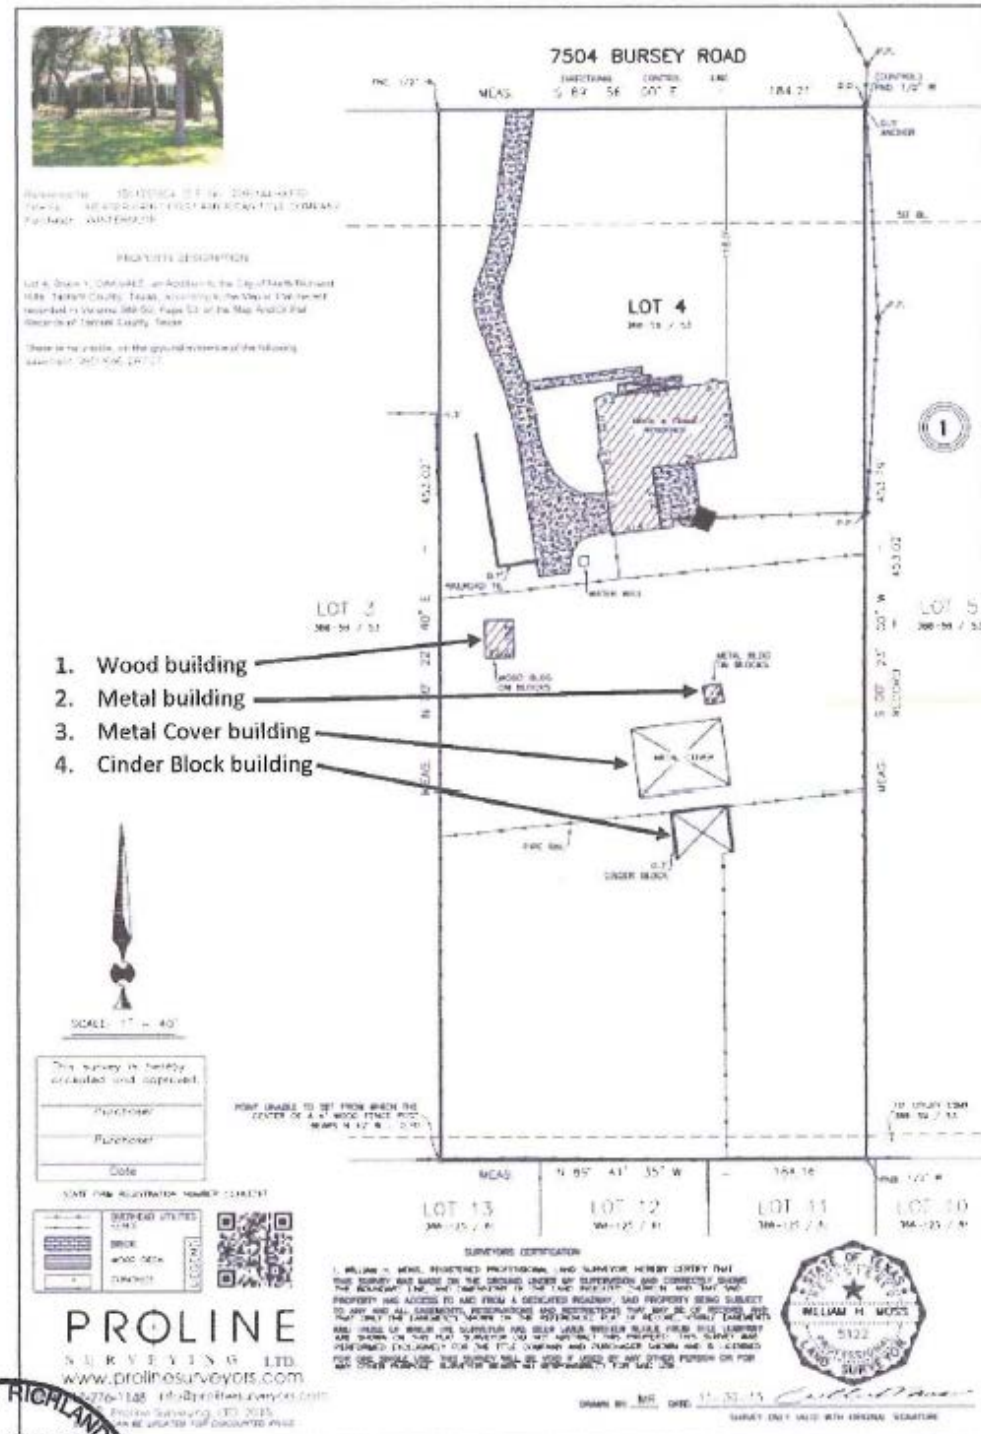

Pictures of Existing Buildings

